



PARKS AND RECREATION ADVISORY COMMISSION - PRAC

Wednesday, October 10, 2018

Lakeside Park Garden Center – 666 Bellevue Avenue

Draft Agenda

1. CALL TO ORDER:
2. ROLL CALL:
AIKENS, COLE, CORBIN, HA, HOWZE, KADERA-REDMOND, MOORE, NORMAN, REILLY, TORRES, AND WOLFSON
3. DISPOSITION OF MINUTES:
 - A. September 12 2018 Draft Minutes
4. MODIFICATIONS TO THE AGENDA:
5. OPEN FORUM:
6. CONSENT NEW BUSINESS:
None
7. NEW BUSINESS:
 - A. REQUEST RECOMMENDATION TO DEDICATE A COMMEMORATIVE PLAQUE IN MEMORY OF AMEENAH NAFEESAH ROSHIMA SCOTT.
 - B. REQUEST FOR THE PARKS AND RECREATION ADVISORY COMMISSION TO APPROVE DESIGN AND IMPLEMENTATION AND RECOMMEND APPROVAL OF A CONDITIONAL USE PERMIT FOR BALLFIELD LIGHTING IMPROVEMENTS AT CURT FLOOD FIELD AND MAJOR ZONING VARIANCES FOR BALLFIELD LIGHTING IMPROVEMENTS AT GOLDEN GATE, LOWELL AND TASSAFARONGA FIELDS.
 - C. REQUEST FOR THE PARKS AND RECREATION ADVISORY COMMISSION TO REVIEW AND PROVIDE COMMENT ON THE TWO (2) GIFT IN PLACE DESIGN OPTIONS BY OAKLAND ARTIST MUZAE SESAY FOR THE RAINBOW RECREATION CENTER PUBLIC ART PROJECT IN EAST OAKLAND, WITH FINAL DESIGN TO BE SELECTED BY TEENS OF THE DIGITAL ARTS AND CULINARY ACADEMY (DACA).
8. PLANNING AND CONDITIONAL USE PERMITS:
9. COMMITTEE AND/OR ADVISORY COUNCIL UPDATES:
10. ANNOUNCEMENTS AND COMMUNICATIONS:
11. DIRECTOR'S REPORT:

12. CONTINUATION OF OPEN FORUM:

13. ADJOURNMENT:

Next Meeting:

Wednesday, November 14, 2018

Lakeside Park Garden Center

666 Bellevue Ave, Oakland, CA

This meeting location is wheelchair accessible. To request disability-related accommodations or to request an ASL, Cantonese, Mandarin or Spanish interpreter, please email dboyd@oaklandnet.com or call (510) 238-7532 or TDD/TTY (510) 238-3254 at least five working days before the meeting. Please refrain from wearing scented products to this meeting as a courtesy to attendees with chemical sensitivities.

Esta reunión es accesible para sillas de ruedas. Si desea solicitar adaptaciones relacionadas con discapacidades, o para pedir un intérprete de en español, Cantones, Mandarín o de lenguaje de señas (ASL) por favor envíe un correo electrónico a dboyd@oaklandnet.com o llame al (510) 238-7532 o (510) 238-3254 por lo menos cinco días hábiles antes de la reunión. Se le pide de favor que no use perfumes a esta reunión como cortesía para los que tienen sensibilidad a los productos químicos. Gracias.

會場有適合輪椅出入設施。需要殘障輔助設施, 手語, 西班牙語, 粵語或國語翻譯服務, 請在會議前五個工作天電郵 dboyd@oaklandnet.com 或致電 (510) 238-7532 或 (510) 238-3254 TDD/TTY。請避免塗搽香氛產品, 參加者可能對化學成分敏感。



PARKS AND RECREATION ADVISORY COMMISSION - PRAC

Wednesday, September 12, 2018

Lakeside Park Garden Center – 666 Bellevue Avenue

Draft Minutes

1. CALL TO ORDER: 4:34p.m.

2. ROLL CALL:

AIKENS, COLE, CORBIN, HA, HOWZE, KADERA-REDMOND, MOORE, NORMAN, REILLY, TORRES, WOLFSON

Present: 7 – Aikens, Cole, Corbin, Kadera-Redmond, Moore, Norman, Reilly

Excused: 4 – Ha, Howze, Torres, Wolfson

Staff: Parks and Recreation - Director Nicholas Williams, Dana Riley, Desmona Armstrong, Zermaine Thomas (Acting Recording Secretary)

3. DISPOSITON OF MINUTES:

A. June 13, 2018 Draft Minutes

Motion: Commissioner Cole entertained a motion to approve the Disposition of Draft Minutes for June 13, 2018. **Second by:** Commissioner Corbin **Vote: 7 Yes:** Aikens, Cole, Corbin, Kadera-Redmond, Moore, Norman, Reilly **Motion:** Passed

B. July 11, 2018 Draft Minutes

Note: Insufficient quorum to make a motion to approve the July 11, 2018 draft meeting minutes.

4. MODIFICATIONS TO THE AGENDA:

N/A

5. OPEN FORUM:

12 Speakers spoke during Open Forum

- Sean Maher: City of Oakland, Capital Improvement Program Update
- Donald Bordenave: Black & Veatch for Extenet System: Small Cell Sites around Lake Merritt
- Lisa Hire: Friends of the Oakland Municipal Band Update on Summer Concerts at Edoff Memorial Bandstand
- Susan Pierpoint: North Oakland Village would like to incorporate a Senior Playground.
- Katie Noonan & Miriam Valesco: Rotary Nature Center supporters providing updates on the process.

- 7 speakers for Pickleball requesting a park in Oakland that will accommodate the fast-growing sport.

6. CONSENT NEW BUSINESS:

A. REQUEST APPROVAL FROM THE PARKS AND RECREATION ADVISORY COMMISSION TO GRANT PERMISSION TO ALLOW THE AMERICAN FOUNDATION FOR SUICIDE PREVENTION (AFSP) TO COLLECT ON SITE CHARITABLE DONATIONS AT THIER OUT OF THE DARKNESS WALK AT LAKESIDE PARK PERGOLA ON SATURDAY, OCTOBER 13, 2018, FROM 6:00AM – 10:00AM.

B. REQUEST APPROVAL TO ALLOW OAKLAND EAST BAY GARDEN CENTER, INC. AND OAKLAND PUBLIC WORKS TO COLLECT FUNDS ON SITE AT THE ANNUAL AUTUMN LIGHTS FESTIVAL/FUNDERAISER AT LAKESIDE PARK GARDEN CENTER AND THE GARDENS AT LAKE MERRITT ON THURSDAY, OCTOBER 18, 2018 – SATURDAY, OCTOBER 20, 2018, FROM 6:00PM-11:00PM.

Motion: Commissioner Kadera-Redmond entertained a motion to approve the Consent 6A-6B. **Moved by:** Commissioner Reilly. **Second by:** Commissioner Cole. **Vote: 7 Yes:** Aikens, Cole, Corbin, Kadera-Redmond, Moore, Norman, Reilly. **Motion Passed**

7. NEW BUSINESS:

A. REQUEST RECOMMENDATION TO DEDICATE A BENCH AND DEDICATION PLAQUE IN CELEBRATION OF ALAN JUNG AND SUSAN LO.
The Parks and Recreation Advisory Commission revisited the staff report prepared by Gail McMillon from Oakland Parks and Recreation & Youth Development which is being submitted again to gain approval to dedicate a bench and dedication plaque in celebration of Alan Jung and Susan Lo's 25th Wedding Anniversary.

Motion: Commissioner Kadera-Redmond entertained a motion to approve the request to dedicate a bench and plaque in celebration of Alan Jung and Susan Lo. **Moved by:** Commissioner Reilly. **Second by:** Commissioner Aikens. **Vote: 5 Yes:** Aikens, Cole, Kadera-Redmond, Moore, Reilly. **Abstain: 2:** Corbin and Norman. **Motion Failed.**

B. RECOMMEND CHANGE OF USE DESIGNATION OF MINOR UNNAMED TRAIL CONNECTING SUNSET LOOP TRAIL TO SUNSET TRAIL IN JOAQUIN MILLER PARK TO MULTI-USE

The Parks and Recreation Advisory Commission reviewed the staff report prepared and presented by Dana Riley from Oakland Parks and Recreation & Youth Development where Friends of Sausal Creek (FOSC) is finalizing the next version of the "Trails and Tributaries of the Sausal Creek Watershed" trail map for Dimond Canyon, Shepherd Canyon and Joaquin Miller Park. In Joaquin Miller Park, trails are generally designated multi-use if there are no significant safety or environmental issues. The recommendation is change of use designation of minor unnamed trail connecting Sunset Loop Trail to Sunset Trail in Joaquin Miller Park to Multi-Use.

Motion: Commissioner Kadera-Redmond entertained a motion to approve the recommended change of use designation of minor unnamed trail connecting Sunset Loop Trail to Sunset Trail in Joaquin Miller Park to Multi-Use. **Moved by:** Commissioner Corbin. **Second by:** Commissioner Norman. **Vote: 7 Yes:** Aikens, Cole, Corbin, Kadera-Redmond, Moore, Norman, Reilly. **Motion Passed**

C. REQUEST APPROVAL TO ALLOW EAST BAY ROWING CLUB TO SELL ADMISSION TICKETS AT DOOR, SELL RAFFLE TICKETS AND COLLECT FUNDS ONSITE FOR SILENT AUCTION ITEMS, AT THEIR ANNUAL EAST BAY ROWING FUNDRAISER TO BE HELD AT JACK LONDON AQUATIC CENTER ON SATURDAY, NOVEMBER 17, 2018.

The Parks and Recreation Advisory Commission reviewed the staff report prepared and presented by Desmona Armstrong from Oakland Parks and Recreation & Youth Development where the East Bay Rowing Club requested permission to sell admission tickets at the door, sell raffle tickets, and collect funds onsite for silent auction items. All funds raised will go towards equipment expenses and scholarships for Oakland Technical High School athletes at their Annual East Bay Rowing Fundraiser at Jack London Aquatic Center on Saturday, November 17, 2018.

Motion: Commissioner Kadera-Redmond entertained a motion to approve the recommendation for East Bay Rowing Club to collect funds onsite at their Annual Fundraiser to be held at Jack London Aquatic Center. **Moved by:** Commissioner Aikens. **Second by:** Commissioner Moore. **Vote: 7 Yes:** Aikens, Cole, Corbin, Kadera-Redmond, Moore, Norman, Reilly. **Motion Passed**

D. REQUEST APPROVAL FROM THE PARKS AND RECREATION ADVISORY COMMISSION TO ALLOW LUPUS RESEARCH ALLIANCE TO COLLECT ONSITE DONATIONS AT THEIR WALK-A-THON TO BE HELD AT LAKE MERRITT AMPHITHEATRE ON SATURDAY, SEPTEMBER 29, 2018, FROM 3:00PM-7:30PM.

The Parks and Recreation Advisory Commission reviewed the staff report prepared by Wendy Johnson and presented by Desmona Armstrong from Lupus Research Alliance this item was represented on the July Agenda but was not voted on by the Commission due to no representation from the organization. The Commission requested the item to be placed on the September agenda to provide ample notification to the organization to have representation at the September PRAC meeting. There was still no representation from the Lupus Research Alliance. The Commissioners were hesitant to vote on this item due to no representation and this being their first event hosted at a Parks and Recreation park. The Lupus Research Alliance requested permission to collect onsite donations at their Walk-A-Thon to be held at the Lake Merritt Blvd. Amphitheatre on September 29, 2018. All donations will go towards Lupus awareness and research.

Motion: Commissioner Kadera-Redmond entertained a motion to approve the recommendation for Lupus Research Alliance to collect donations onsite at their Walk-A-Thon to be held at Lake Merritt Blvd Amphitheatre. **Moved by:** Commissioner Aikens. **Second by:** Commissioner Reilly **Vote: 6 Yes:** Aikens, Cole, Kadera-Redmond, Moore, Norman, Reilly. **Abstained: 1 Corbin. Motion Passed**

E. REQUEST FOR THE PARKS AND RECREATION ADVISORY COMMISSION TO REVIEW AND RECOMMEND APPROVAL OF THE PUBLIC ART CONCEPTUAL DESIGN PROPOSAL BY ARTIST JOHANNA POETHIG FOR THE RAINBOW RECREATION CENTER PUBLIC ART PROJECT IN EAST OAKLAND.

The Parks and Recreation Advisory Commission reviewed the staff report prepared and presented by Kristen Zaremba, from City of Oakland, Cultural Affairs, Economic & Workforce Development Department where the Public Art Program Staff recommended that the Parks and Recreation Advisory Commission receive, review and recommend approval to the Public Art Advisory Committee for Oakland-based artist Johanna Poethig's design for the Rainbow Recreation Center Public Art Project in East Oakland. The project, is commissioned by the Public Art Program in compliance with the associated grant and bond funds for the new building, that will beautify the facility with artwork compose of a glass mosaic on the building façade. The Parks and Recreation Advisory Commission reviews all public art projects designs proposed for Oakland Parks and Recreation facilities, either as part of a larger capital improvement design review, or when the artwork is designed independently.

Motion: Commissioner Kadera-Redmond entertained a motion to approve the recommendation receive, review and recommend approval to the Public Art Advisory Committee for Oakland-based artist Johanna Poethig's design for the Rainbow Recreation Center Public Art Project in East Oakland. **Moved by:** Commissioner Aikens. **Second by:** Commissioner Moore. **Vote: 7 Yes:** Aikens, Cole, Corbin, Kadera-Redmond, Moore, Norman, Reilly. **Motion Passed**

F. REQUEST REVIEW AND ACCEPTANCE OR APPROVAL OF INFORMATIONAL REPORT: 2017 ANNUAL PROGRESS REPORT ON IMPLEMENTATION OF THE HABITAT ENHANCEMENT PLAN FOR KNOWLAND PARK OAKLAND, CALIFORNIA.

The Parks and Recreation Advisory Commission reviewed the staff report prepared by Dana Reilly and presented by Nik Dehejia and Jim Martin from Knowland Park Zoo requesting review and acceptance or approval of the Informational Report. The Informational Report consisted of 2017 Annual Progress Report on Implementation of the Habitat Enhancement Plan for Knowland Park. A PowerPoint Presentation and handouts were provided to the Commissioners for review during the presentation.

Motion: Commissioner Kadera-Redmond entertained a motion to accept and file or approve the informational report 2017 Annual Progress Report on Implementation of the Habitat Enhancement Plan for Knowland Park Oakland, California. Moved by: Commissioner Norman. Second by: Commissioner Cole. **Vote: 7 Yes:** Aikens, Cole, Corbin, Kadera-Redmond, Moore, Norman, Reilly. **Motion Passed**

8. PLANNING AND CONDITIONAL USE PERMITS:

9. COMMITTEE AND/OR ADVISORY COUNCIL UPDATES:

- Mosswood Staff and Kids have relocated to portables at Mosswood Park.
- Mosswood Staff and Kids attending Bay to Creek Day on Saturday, September 15, 2018

10. ANNOUNCEMENTS AND COMMUNICATIONS:

- Emergency Communication

Note: This item will be addressed by Chair Kadera-Redmond upon her return in September. Reference: June's discussion regarding the possibility for the City/OPRYD to inform the community of event cancellations when air quality or other emergency warnings are imposed.

- Nicholas Williams addressed the Emergency Communication by stating he receives Fire Alerts from the Fire Department regarding High Fire Danger Days. OPRYD youth outdoor activities are cancelled based upon the recommendation from the Fire Department. OPRYD and Oakland Fire works very close when it comes to ensuring the safety of kids and park visitors.
- Vote/Discussion: Regarding successor Chair and or Vice Chair. There was no vote but a discussion among the Commissioner's needing more details on the role of PRAC Chair and Vice Chair. More discussion required. It was decided that this would be a topic for the Retreat that both Commissioner Norman and Cole agreed to assist with the planning.

- Commissioner Corbin provided information on a meeting being held at a Church located at 1330 Lakeshore Avenue regarding Banning Homelessness and Encampments in Parks.

11. DIRECTOR'S REPORT:

- Warrior's Front Office and Volunteers held a community event at Brookdale Recreation Center. The following was done at the community event:
 - Painted inside of recreation center
 - Replaced furniture in recreation center and gifted center with a flat screen television
 - Landscaped the outside of recreation center
 - Hosted a free basketball clinic
 - Backpack Give-Away with school supplies
- NPRA Conference
 - Several OPRYD staff attending conference
 - Commissioner Norman also suggested staff attend the Cleaner Greener Conference on Urban Cities held in San Francisco
- Sunday's In The Redwoods (SITR) (9/23, 9/30, 10/7, 10/14)
 - The Director offered PRAC a table for SITR

12. CONTINUATION OF OPEN FORUM:

None

13. ADJOURNMENT: 7:04p.m.

Respectfully submitted,

/s/ J. Nicholas Williams

J. Nicholas Williams
Secretary

/s/ Zermaine Thomas

Zermaine Thomas
Acting Recording Secretary

Next Meeting:

***Wednesday, October 10, 2018
Lakeside Park Garden Center
666 Bellevue Ave, Oakland, CA***

This meeting location is wheelchair accessible. To request disability-related accommodations or to request an ASL, Cantonese, Mandarin or Spanish interpreter, please email dboyd@oaklandnet.com or call (510) 238-7532 or TDD/TTY (510) 238-3254 at least five working days before the meeting. Please refrain from wearing scented products to this meeting as a courtesy to attendees with chemical sensitivities.

Esta reunión es accesible para sillas de ruedas. Si desea solicitar adaptaciones relacionadas con discapacidades, o para pedir un intérprete de en español, Cantonés, Mandarín o de lenguaje de señas (ASL) por favor envíe un correo electrónico a dboyd@oaklandnet.com o llame al (510) 238-7532 o (510) 238-3254 por lo menos cinco días hábiles antes de la reunión. Se le pide de favor que no use perfumes a esta reunión como cortesía para los que tienen sensibilidad a los productos químicos. Gracias.

會場有適合輪椅出入設施。需要殘障輔助設施, 手語, 西班牙語, 粵語或國語翻譯服務, 請在會議前五個工作天電郵 dboyd@oaklandnet.com 或致電 (510) 238-7532 或 (510) 238-3254 TDD/TTY。請避免塗搽香氛產品, 參加者可能對化學成分敏感。



**CITY OF OAKLAND
Oakland Parks, Recreation & Youth Development**

TO: Mandolin Kadera-Redmond, Chair, Parks and Recreation Advisory Commission
FROM: Gail McMillon, Parks, Recreation & Youth Development
DATE: September 24, 2018
**SUBJECT: REQUEST RECOMMENDATION TO DEDICATE A COMMEMORATIVE
PLAQUE IN MEMORY OF AMEENAH NAFEESAH ROSHIMA SCOTT**

SUMMARY

Staff received a request to install a commemorative dedication plaque in memory of Ameenah Nafeesah Roshima Scott (Ameenah). The selected location for the plaque is at an existing bench at Lake Merritt / Lakeside Park facing the lake in the 1300 block of Lakeshore Avenue. The plaque is dedicated by Ameenah's mother, Mercedes S. Rodriguez and she would like it to read:

In Loving Memory of
Ameenah Nafeesah Roshima Scott
February 21, 1965 – December 23, 1981
Beloved daughter, sister, friend and honor student

FISCAL IMPACT

Donation of \$800 will be made to the Oakland Parks and Recreation Foundation for purchase and installation of the plaque. Oakland Public Works will install the plaque in accordance with the department construction requirements. The donor will assist with maintaining the plaque by washing the plaque every few months with soft cloth, water and a mild dish washing liquid.

BACKGROUND / LEGISLATIVE HISTORY

Ameenah Nafeesah Roshima Scott was killed on December 23, 1981 at the age of 16. Her body was found on the grounds of Lowell Jr. High School on the morning of December 24, 1981 and her murder was never solved.

Ameenah was an honors student and had graduated from Lowell Jr. High School prior to going to McClymonds High School. She attended the University of California, Berkeley on a partnership program taking college preparatory classes through the Oakland Unified School District from the 7th grade until her transition and was also working a few days a week after school at Prescott Elementary School.

 
The McClymonds High School 1983 Graduation was held on December 30, 1983 in honor of Ameenah. She was ranked among the top five in her class when she died. The 165 classmates who received their degrees voted unanimously to award Ameenah the honorary diploma that Ms. Rodriguez accepted on her daughter's behalf. McClymonds Senior Class Counselor, Johnny Lorigo, was responsible for initiating the graduation in Ameenah's honor. Mr. Lorigo told the graduates that Ameenah was the epitome of a McClymonds student - determined, energetic, kindhearted and very intelligent. To this day, people that knew Ameenah come up to Ms. Rodriguez and talk to her about how wonderful a person her daughter was.

Ameenah's cold case has recently been re-opened and Oakland Police Officer Phong T. Tran is currently working on the assignment.


RECOMMENDATION

Staff recommends that the Parks and Recreation Advisory Commission recommend approval of the commemorative plaque language as written in memory of Ameenah Nafeesah Roshima Scott.

Respectfully submitted,



Prepared by: Gail McMillon
Office Manager

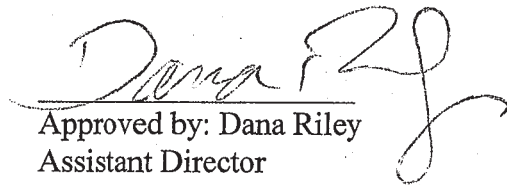

Approved by: Dana Riley
Assistant Director



**CITY OF OAKLAND
Oakland Parks & Recreation**

TO: Mandolin Kadera-Redmond, Chair, Parks and Recreation Advisory Commission
FROM: Christine Reed, Oakland Public Works - Project Delivery Division
DATE: October 10, 2018
SUBJECT: **REQUEST FOR THE PARKS AND RECREATION ADVISORY COMMISSION TO APPROVE DESIGN AND IMPLEMENTATION AND RECOMMEND APPROVAL OF A CONDITIONAL USE PERMIT FOR BALLFIELD LIGHTING IMPROVEMENTS AT CURT FLOOD FIELD AND MAJOR ZONING VARIANCES FOR BALLFIELD LIGHTING IMPROVEMENTS AT GOLDEN GATE, LOWELL AND TASSAFARONGA FIELDS.**

SUMMARY

Staff from the Oakland Public Works Department (OPW) and Oakland Parks, Recreation, and Youth Development Department (OPRYD) request approval of the design and implementation, and endorsement of a Conditional Use Permit for ballfield lighting improvements at Curt Flood Field and Major Zoning Variances for ballfield lighting improvements at Golden Gate, Lowell and Tassafaronga Fields. These four projects, funded by Measure KK Bond funds, include lighting upgrades and associated electrical wiring improvements for existing athletic ballfields. The improvements will upgrade the fields to meet safe play standards and improve energy efficiency.

FISCAL IMPACT

Staff anticipates no new or additional fiscal impact to OPRYD from the proposal. The estimated project cost is \$2,059,000. The project is currently funded by Measure KK Bond funds and Measure WW bond funds. Additional funding is currently being sought to fulfill anticipated construction costs. Staff anticipates that the project will have some increase to existing on-going maintenance of the Park. However, it is consistent with on-going maintenance requirements of sports lighting at all City-owned parks.

PROJECT / PROGRAM DESCRIPTION

The proposed Ballfield Wiring and Lighting Improvement Project would allow upgrades to existing athletic field lighting and associated electrical wiring improvements for four existing City-owned parks. Existing conditions at the four ballfields were determined by City staff to be hazardous due to theft of existing lighting equipment and wiring, possible leaking of electrical current from damaged wires and equipment, and inadequate light levels to support night time play. In general, the existing lighting conditions at the ballfields are inadequate for safe play for their current athletic uses. The existing lighting systems vary from 25 to over 35 years old. When the design consultants ran an analysis of the existing lower-height sports pole lighting, they determined that there was unacceptably high spill-light and disturbing levels of glare into neighborhoods.

The goals of the improvement projects are to restore softball lighting system functionality, expand the sports lighting system to include baseball, meet safe play illumination standards, reduce spill-light and glare into the neighborhoods, reduce on-going maintenance costs and improve energy efficiency. The new LED fixtures will control light spillage off the fields, eliminate dark spots on the fields, have longer lifespan and reduced energy demand. New wireless remote-control systems will allow City staff to program field light operation without need for visiting sites.

For current lighting to properly illuminate the fields, lights must be angled in a manner that causes glare and increased light pollution onto adjacent properties. Use of taller light poles than those now installed at Tassafaronga, Curt Flood and Lowell, will allow the fields to be more effectively lighted with minimal spill to adjacent properties (Attachment B). Results of a computer-predicted illumination study for the proposed lighting design have determined that the system will improve glare control and reduce spill light compared with existing conditions.

Ballfield address locations, existing athletic field types and community groups served:

Curt Flood Field, 3303 Laguna Way (Coolidge Ave & School Street) – baseball, softball, football & soccer

- Fremont High school – Varsity & Jr. Football and Baseball teams
- Oakland Girls' Softball teams
- Oakland Parks and Recreation Development Baseball Camps
- Oakland Parks and Recreation Adult Softball Leagues
- Oakland Dynamites Youth Football team
- Fruitvale Elementary school
- Oakland Babe Ruth Youth Baseball
- OPR Baseball League

Golden Gate Field, 1075 62nd Street – baseball, softball, soccer

- Oakland Girls' Softball teams
- Oakland Parks and Recreation Development Baseball Camps
- Oakland Parks and Recreation Adult Softball Leagues
- Oakland Babe Ruth Youth Baseball League
- Jack London Youth Soccer Club
- NOLL/SOLL Youth Baseball League

Lowell Field, 1206 12th Street – baseball, softball, basketball

- Oakland Parks and Recreation Adult Softball Leagues
- Oakland Babe Ruth Youth Baseball League
- Jack London Youth Soccer Club
- NOLL/SOLL Youth Baseball League
- Adult Soccer Leagues

Tassafaronga Field, 1001 E Street – softball

- Oakland Parks and Recreation Development Baseball Camps
- Oakland Parks and Recreation Flag Football League
- Oakland Babe Ruth Youth Baseball League
- Jack London Youth Soccer Club
- NOLL/SOLL Youth Baseball League

Curt Flood has a Zoning use classification of OS Open Space (AF – Athletic Field) that permits Sports Lighting. Its Conditional Use Permit (CUP) will allow for the addition of new sport light poles to provide for complete field coverage (softball, baseball and football).

The remaining three parks have Zoning use classification of OS Open Space (NP – Neighborhood Park). The OS zone is intended to meet the active and passive recreational needs of Oakland residents and to promote park uses which are compatible with surrounding land uses and the City’s natural environment. Those parks each have multiple athletic fields, some with existing sports lighting (Lowell being the exception) and are heavily used. The addition of new sports lighting will greatly improve the availability of those fields to meet recreational needs and will therefore require a Major Variance.

The anticipated project schedule is as follows:

Current Status	95% Construction Documentation and Permit Application
Spring-Summer 2019	Advertise and Bid Period
Fall 2019	Construction

BACKGROUND / LEGISLATIVE HISTORY

The adopted Capital Improvement Program Budget for fiscal years 2017 – 2019 approved and allocated \$1,000,000 in Measure KK bond funding for the ‘Ballfield Wiring and Hazard Mitigation Project’ for four City-owned ballfields: Curt Flood, Golden Gate, Lowell and Tassafaronga Fields. This project was deemed one of the top priority CIP requests from Oakland Public Works Bureau of Facilities and Environment (OPW-BFE) for capital improvement due to life safety, hazard elimination and preventative maintenance concerns.

Several existing City athletic ballfields exist on park sites with the Zoning designation ‘Open Space Neighborhood Park’. In 2011, the Planning Commission approved Major Variances for Owen Jones and Poplar Parks, allowing the improvement of athletic field lighting at neighborhood parks, with very similar circumstances to those being proposed with these current project proposals.

RECOMMENDATION

Staff recommends that the Parks and Recreation Advisory Commission approval of the design and implementation of all four fields, and endorse and recommend approval of the proposed Conditional Use Permit for Curt Flood Field and Major Zoning Variances for Golden Gate, Lowell and

Tassafaronga Fields Ballfield Lighting and Wiring Improvement Projects. The proposed projects will improve the usability of existing athletic facilities to better serve the recreational needs of the surrounding area, improve safety, and reduce light spillage onto adjacent properties.

Respectfully submitted,



Prepared by: Christine Reed, RLA
Capital Improvement Project Coordinator, OPW-PDD



Approved by:
Lily Soo Hoo
Supervisor, OPW-PDD

Attachments: Exhibit A – *Property Maps with Proposed Improvements*
Exhibit B – *Diagram of Mounting Height and Spill Control*

SITE PLAN

LOCATION MAP

1 LOWELL PARK

SITE PLAN

LOCATION MAP

2 GOLDEN GATE PLAYGROUND

SITE PLAN

LOCATION MAP

3 CURT FLOOD FIELD

SITE PLAN


LOCATION MAP

4 TASSAFARONGA PARK

<p>CITY OF OAKLAND DEPARTMENT OF ENGINEERING AND CONSTRUCTION 250 FRANK OAKWA PLAZA, OAKLAND, CA 94612 (510) 258-5307 • FAX: (510) 258-2527</p>	<p>BALLFIELD WIRING HAZARD MITIGATION AND LIGHTING PROJECT, CITY OF OAKLAND</p>			<p>ZEIGER ENGINEERS, INC. ELECTRICAL CONSULTANTS TEL: (916) 424-2200 • FAX: (916) 424-2009 CHECKED BY: [Signature] OL DESIGNED BY: [Signature] RZ DRAWN BY: [Signature] AG</p>		<p>SITE PLANS & LOCATION MAPS</p>		<p>PROJECT NO. _____ SHEET NO. E1.2 SCALE: _____ VERT: _____ DATE: 01/06/2018</p>
	<p>Dillingham Associates Landscape Architects 2527 Newbury Street Berkeley, CA 94704 Tel: 510.548.4700 Fax: 510.548.0285 www.dillinghamlandscape.com</p>			<p>REFERENCE _____ DATE _____ BY _____</p>		<p>4 BALLFIELDS</p>		

SHEET NOTES:

- 1 NOT USED
- 2 NEW 2 EA - 30' GALVANIZED STEEL POLE WITH LED LUMINAIRES BY NLS LIGHTING VIE SERIES 39AH, CONCRETE FOUNDATION, 5' DEEP
- 3 SPORT LIGHT WITH HIGH/LOW CONTROL FOR NIGHT SECURITY
- 4 (N) 2'C, 4 #10 + #10 GND TO PANEL L1
- 5 RESTORE WIRING TO LIGHT POLE & MAKE OPERATIONAL
- 6 HOMERUN TO (E) PANEL 'P1' VIA LIGHTING CONTROLS, SEE SINGLE LINE
- 7 HOMERUN TO (E) PANEL 'L1' VIA LIGHTING CONTROLS, SEE SINGLE LINE

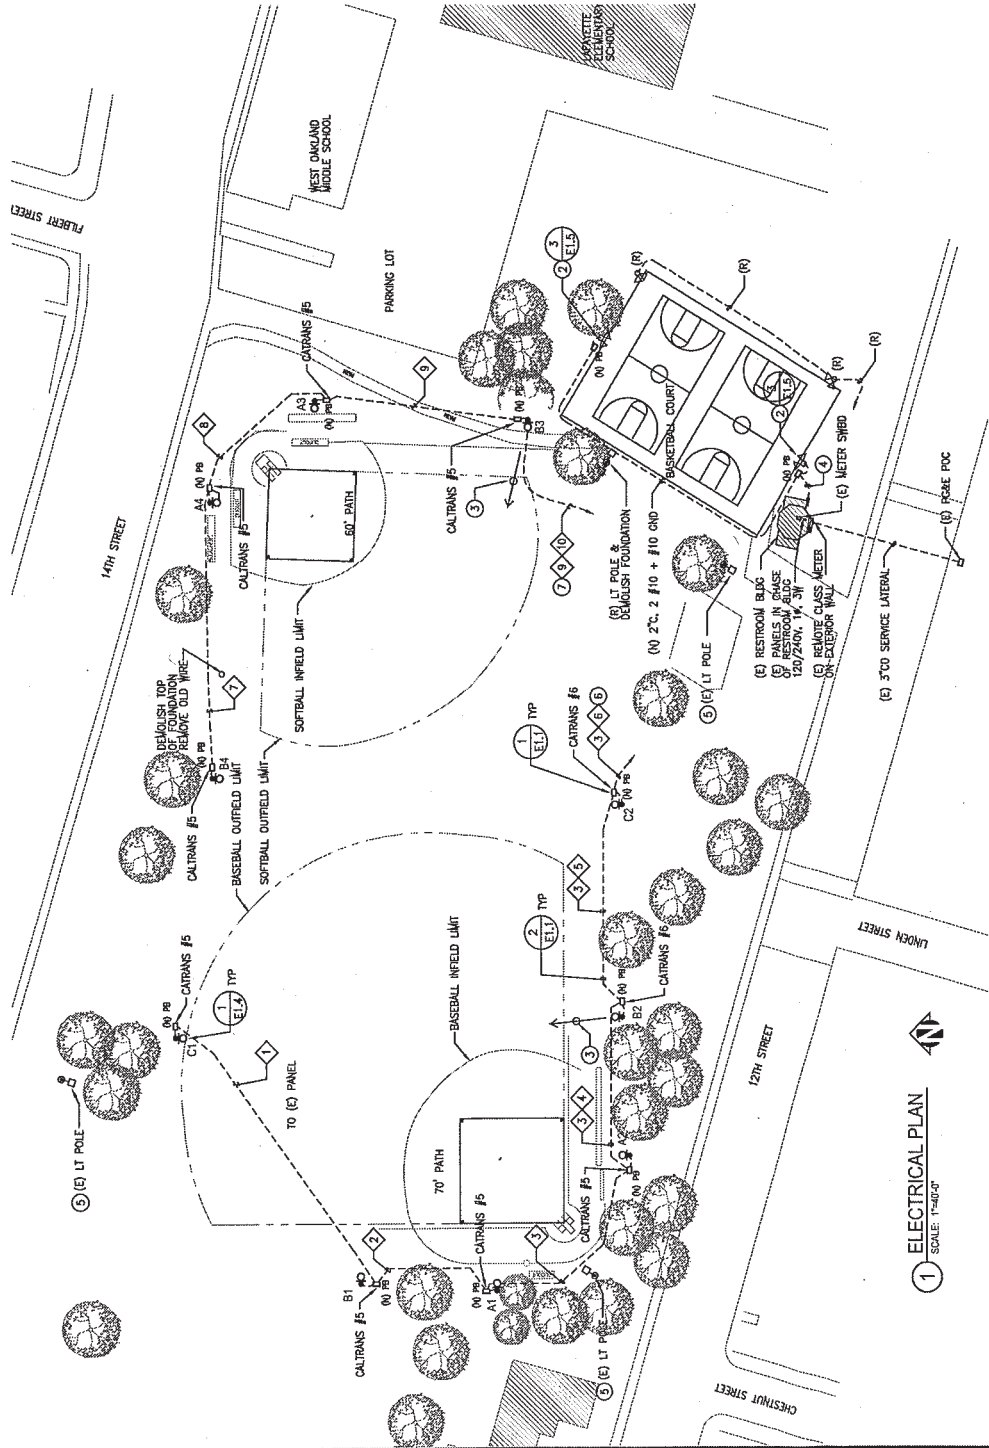

BALLFIELD SPORTS LIGHTING					REMARKS
FIELD POLES	POLE ID	HEIGHT	QUANTITY PER POLE	LUMINAIRES	
				ED WATTS PER POLE	TOTAL WATTS PER POLE
	A1	70'	3	600	1800
	A2	70'	3	575	1725
	A3	70'	3	575	1725
	A4	70'	3	575	1725
	B1	70'	4	1150	4600
	B2	70'	3	1150	3450
	B3	70'	2	1150	2300
	B4	70'	4	1150	4600
	C1	70'	4	1150	4600
	C2	70'	3	1150	3450
				TOTAL:	39400

95% CD SET

PROJECT NO. _____

LOWELL PARK
1180 14TH STREET
OAKLAND, CA 94607

SCALE: _____
SHEET NO. E2.2
DATE: 01/28/2018

ZIEGLER ENGINEERS, INC.
ELECTRICAL CONSULTANTS
478 9th STREET, OAKLAND, CA 94607
TEL: 510-832-0888 FAX: 510-832-0888


CHECKED BY: _____
DESIGNED BY: _____
DRAWN BY: _____

Dillingham Associates
Landscape Architects
2827 Newbury Street
Berkeley, California 94703
Tel: 510-546-4700 Fax: 510-546-0285
www.dillinghamassociates.com

BALLFIELD WIRING HAZARD
MITIGATION AND LIGHTING
PROJECT, CITY OF OAKLAND

CITY OF OAKLAND
DEPARTMENT OF ENGINEERING AND CONSTRUCTION
250 FINE LANE, OAKLAND, CA 94612
510-233-3300 FAX: 510-233-3322

1 ELECTRICAL PLAN
SCALE: 1"=50'-0"

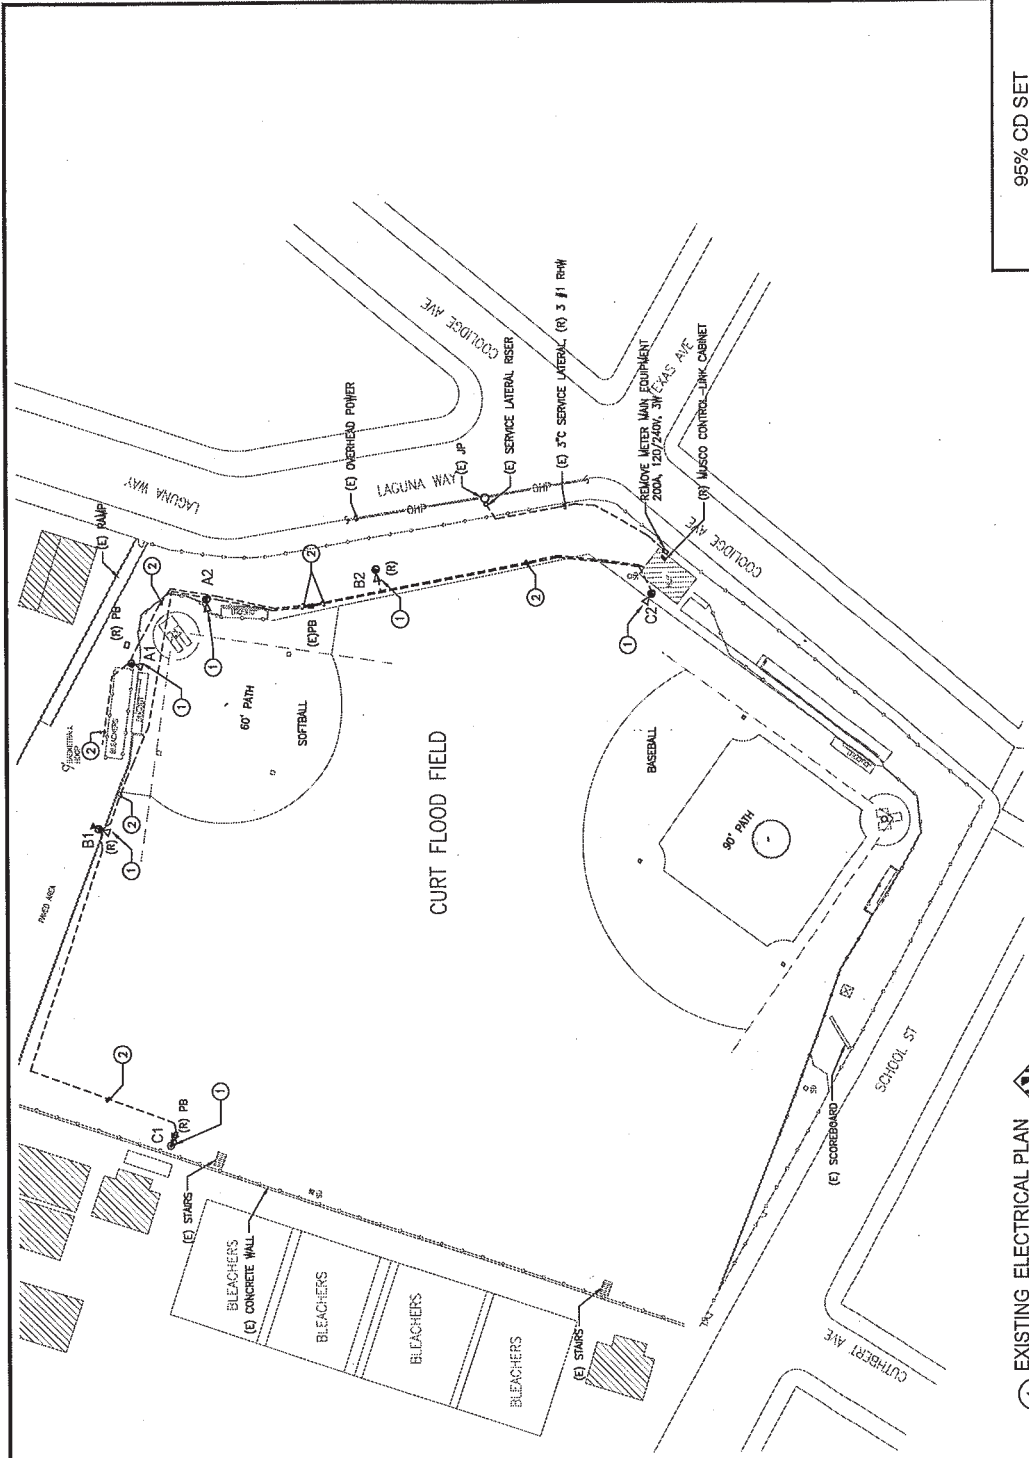

EXISTING SPORTS LIGHTING				REMARKS	
FIELD	POLES	LUMINAIRES	WPS WATTS PER FIXT		
SOFTBALL FIELD	A1	50'	1	1000	REMOVE POLE & DEMOLISH
	A2	50'	1	1000	REMOVE POLE & DEMOLISH
	B1	BACK LT	1	1000	REMOVE POLE & DEMOLISH
	B2	50'	1	1000	REMOVE POLE & DEMOLISH
	C1	60'	1	1000	REMOVE POLE & DEMOLISH
	C2	60'	1	1000	REMOVE POLE & DEMOLISH
BASEBALL FIELD				NONE	

SHEET NOTES:

- ① REMOVE POLE, LUMINAIRES & FOUNDATION
- ② REMOVE EXISTING Wires, CUT CONDUITS, BEOL, GRADE, (NO STAY OUT) & REVISION CONDUIT IN PLACE

EXISTING ELECTRICAL PLAN
SCALE: 1"=30'-0"

95% CD SET

PROJECT NO. _____

SHEET NO. E3.2

SCALE: _____

HOR: _____

VERT: _____

DATE: 01/05/2018

EXISTING ELECTRICAL PLAN

CURT FLOOD FIELD

2988 SCHOOL STREET

OAKLAND, CA 94602

PROJECT NO. _____

SHEET NO. E3.2

SCALE: _____

HOR: _____

VERT: _____

DATE: 01/05/2018

1 EXISTING ELECTRICAL PLAN

SCALE: 1"=30'-0"

95% CD SET

PROJECT NO. _____

SHEET NO. E3.2

SCALE: _____

HOR: _____

VERT: _____

DATE: 01/05/2018

BALLFIELD WIRING HAZARD MITIGATION AND LIGHTING PROJECT, CITY OF OAKLAND

PROJECT NO. _____

SHEET NO. E3.2

SCALE: _____

HOR: _____

VERT: _____

DATE: 01/05/2018

CITY OF OAKLAND

DEPARTMENT OF ENGINEERING AND CONSTRUCTION

205 FINE OAKWAY PLAZA, OAKLAND, CA 94612

(916) 258-5427 • FAX: (916) 238-7229

PROJECT NO. _____

SHEET NO. E3.2

SCALE: _____

HOR: _____

VERT: _____

DATE: 01/05/2018

Dillingham Associates

Landscape Architects

2827 Newbury Street, Oakland, CA 94609

tel: 510.546.4700 fax: 510.546.0295

www.dillinghamlandscape.com

PROJECT NO. _____

SHEET NO. E3.2

SCALE: _____

HOR: _____

VERT: _____

DATE: 01/05/2018

ZEIGER ENGINEERS, INC.

475 5th STREET, OAKLAND, CA 94607

TEL: 510-862-8501 FAX: 510-862-0991

CHECKED BY: _____

DESIGNED BY: _____

DRAWN BY: _____

PROJECT NO. _____

SHEET NO. E3.2

SCALE: _____

HOR: _____

VERT: _____

DATE: 01/05/2018

PROFESSIONAL SEAL OF THE ENGINEER

STATE OF CALIFORNIA

NO. 10000

DATE: 01/05/2018

PROJECT NO. _____


SHEET NO. E3.2

SCALE: _____

HOR: _____

VERT: _____

DATE: 01/05/2018

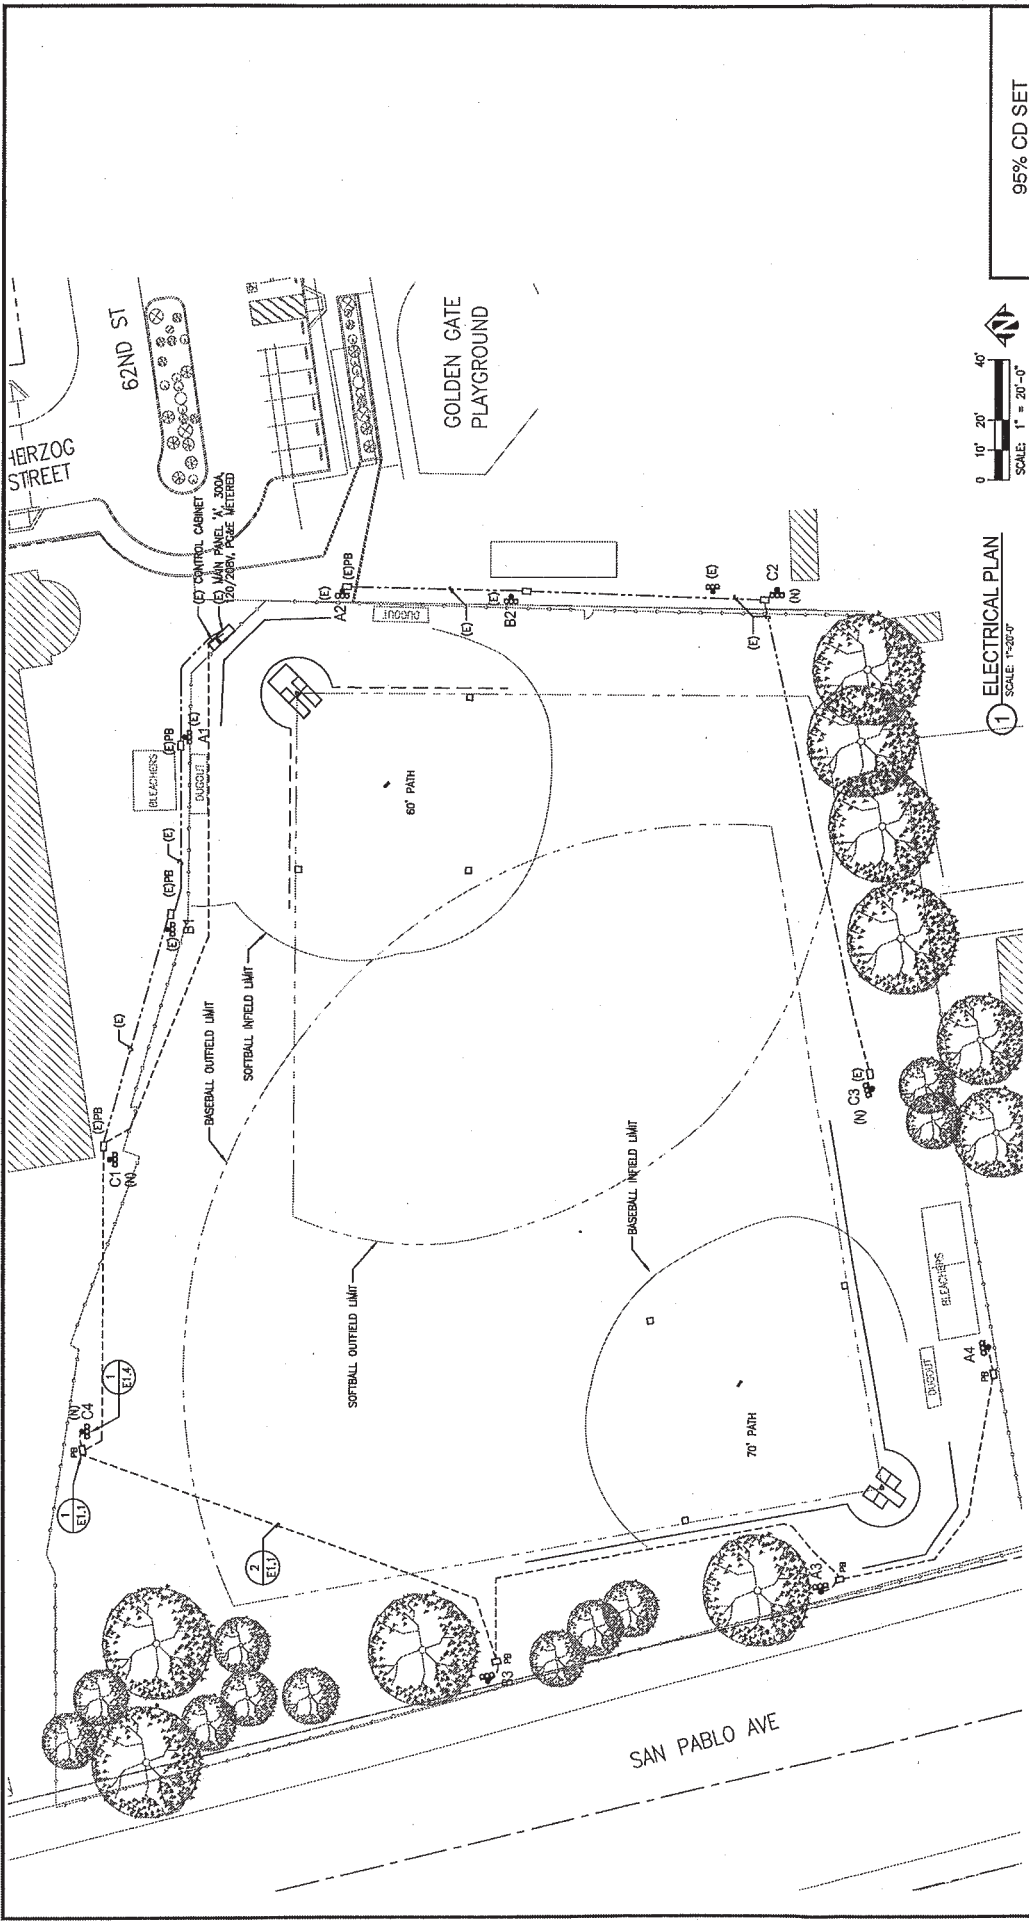


ELECTRICAL PLAN
SCALE: 1"=20'-0"

95% CD SET


	CITY OF OAKLAND DEPARTMENT OF ENGINEERING AND CONSTRUCTION 2501 BAY STREET • FAX 510.238.2227		BALLFIELD WIRING HAZARD MITIGATION AND LIGHTING PROJECT, CITY OF OAKLAND				Dillingham Associates Landscape Architects 2827 Newbury Street Berkeley, California 94703 tel 510.848.4700 fax 510.848.0285 www.dillinghamassociates.com				ZIGLER ENGINEERS, INC. ELECTRICAL CONSULTANTS 475 3RD STREET, OAKLAND, CA 94607 TEL 510-432-0945 FAX 510-432-0991		No. _____ DATE _____ BY _____ REFERENCE _____		ELECTRICAL PLAN GOLDEN GATE PLAYGROUND 1075 62ND STREET OAKLAND, CA 94608		PROJECT NO. _____ SHEET NO. E4.2 SCALE: HORIZ. _____ VERT. _____ DATE: 6/10/2018	
	CITY OF OAKLAND DEPARTMENT OF ENGINEERING AND CONSTRUCTION 2501 BAY STREET • FAX 510.238.2227		BALLFIELD WIRING HAZARD MITIGATION AND LIGHTING PROJECT, CITY OF OAKLAND				Dillingham Associates Landscape Architects 2827 Newbury Street Berkeley, California 94703 tel 510.848.4700 fax 510.848.0285 www.dillinghamassociates.com				ZIGLER ENGINEERS, INC. ELECTRICAL CONSULTANTS 475 3RD STREET, OAKLAND, CA 94607 TEL 510-432-0945 FAX 510-432-0991		No. _____ DATE _____ BY _____ REFERENCE _____		ELECTRICAL PLAN GOLDEN GATE PLAYGROUND 1075 62ND STREET OAKLAND, CA 94608		PROJECT NO. _____ SHEET NO. E4.2 SCALE: HORIZ. _____ VERT. _____ DATE: 6/10/2018	

DATE: 6/10/18
 06:14:13
 10/17/18 BY: CDM

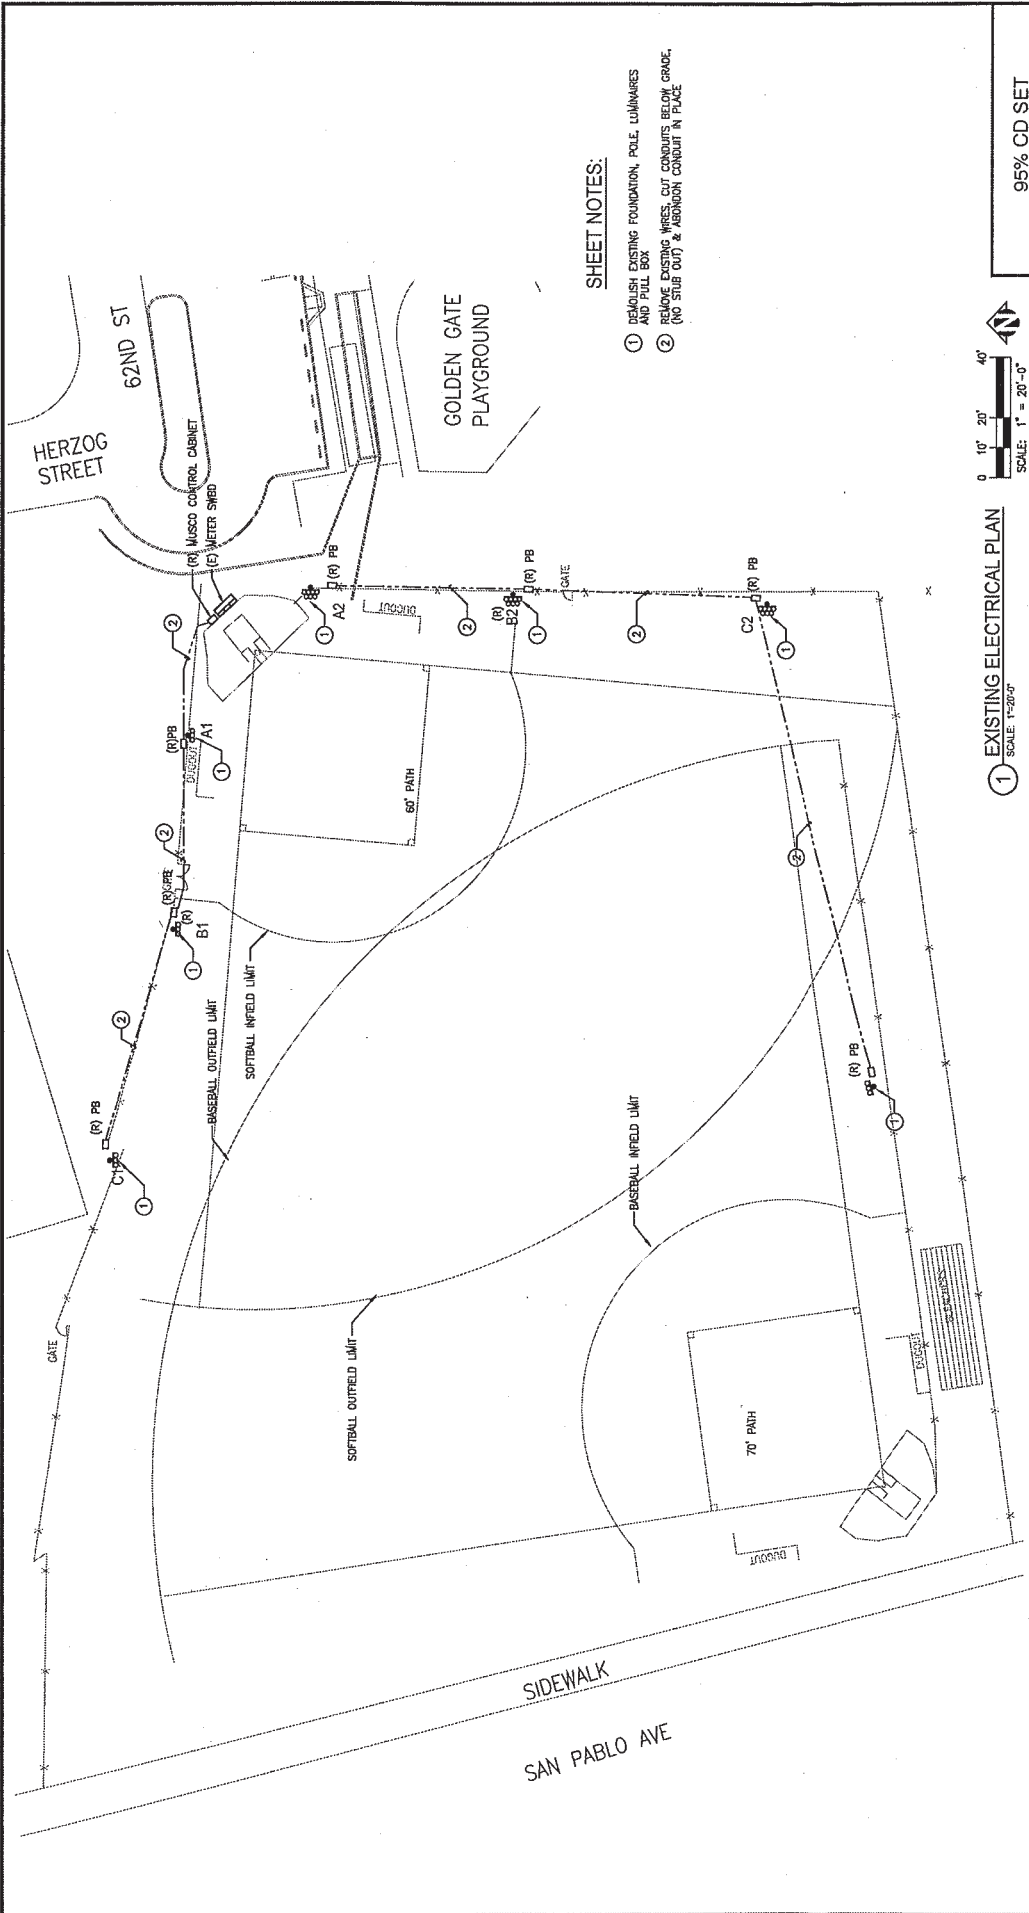

SHEET NOTES:

 - ① DEMOLISH EXISTING FOUNDATION, POLE, LUMINAIRES AND PULL BOX
- ② REMOVE EXISTING WIRES, CUT CONDUITS BELOW GRADE. (NO STUB OUT) & ABANDON CONDUIT IN PLACE



① EXISTING ELECTRICAL PLAN
SCALE: 1" = 20'-0"

PROJECT NO.	
EXISTING ELECTRICAL PLAN	
GOLDEN GATE PLAYGROUND	
1075 62ND STREET	
OAKLAND, CA 94608	
SCALE:	SHEET NO.
HOR:	EA,3
VERT:	
DATE: 03/06/2018	OF: 050 (02/25/18)

ZIEGLER ENGINEERS, INC.
ELECTRICAL CONSULTANTS
478 9th STREET, OAKLAND, CA 94607
TEL: 510-436-0981 FAX: 510-436-0981




LANSCAPE ARCHITECT
Dillingham Associates
Landscape Architects
2827 Newbury Street
Berkeley, California 94703
Tel: 510-548-2700 Fax: 510-548-0285
www.dillinghamlandsc.com

BALLFIELD WIRING HAZARD
MITIGATION AND LIGHTING
PROJECT, CITY OF OAKLAND

CITY OF OAKLAND
DEPARTMENT OF ENGINEERING AND CONSTRUCTION
250 5TH STREET, 5TH FLOOR
OAKLAND, CA 94612
TEL: 510-238-2300 FAX: 510-238-2277



DATE: 03/06/2018

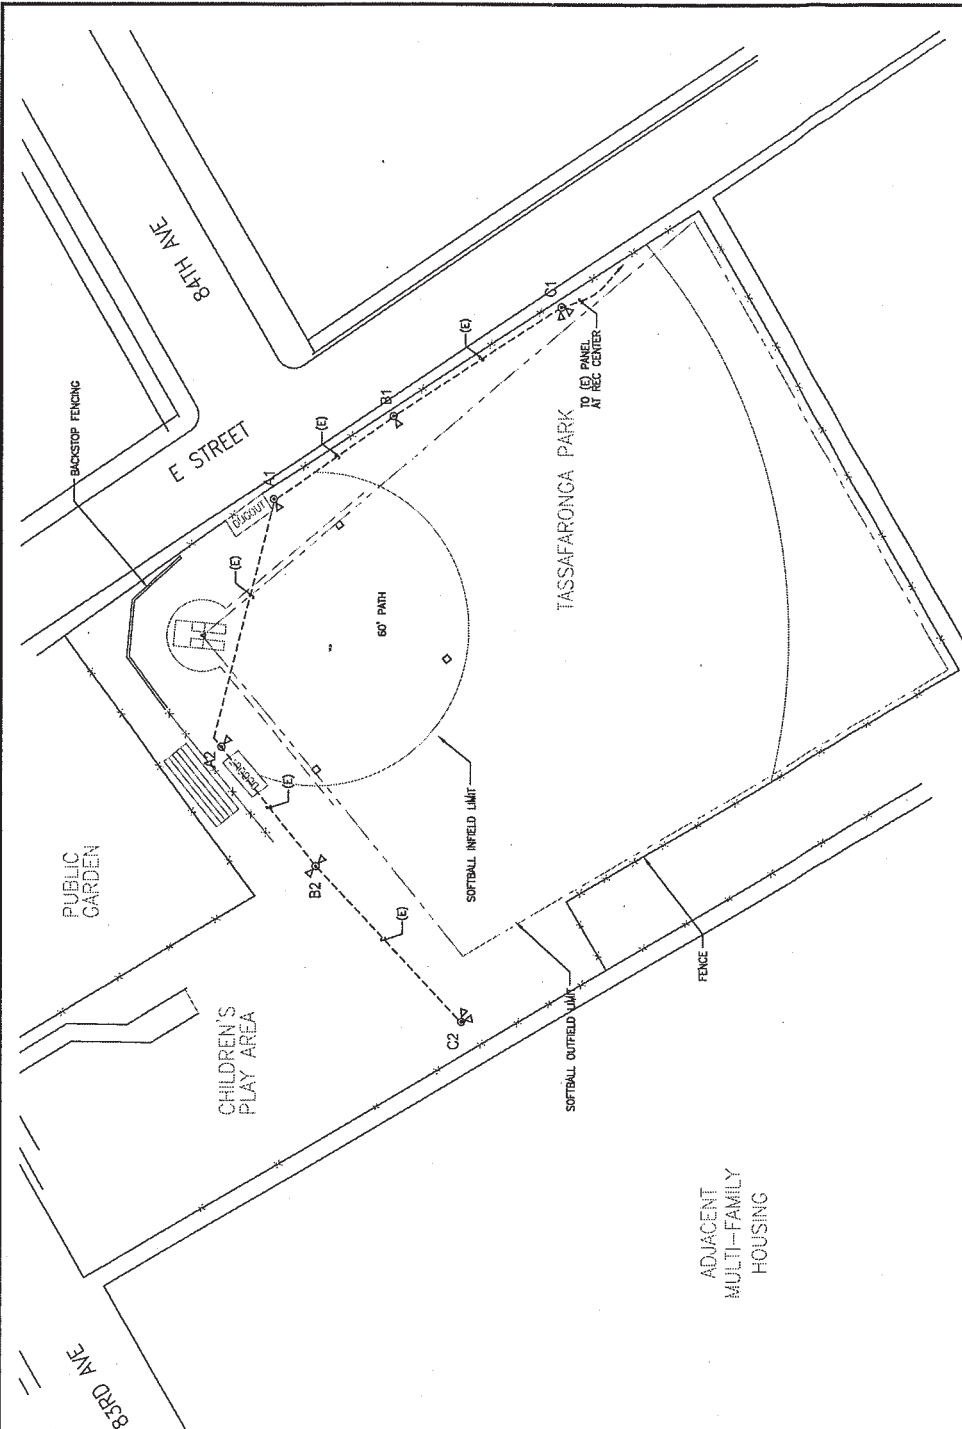

EXISTING ELECTRICAL PLAN
SCALE: 1" = 20'-0"

95% CD SET

EXISTING ELECTRICAL PLAN
TASSAFARONGA FIELD
975 85 AVE
OAKLAND, CA 94621

PROJECT NO. _____
SCALE: _____
SHEET NO. ES.1
DATE: 2/10/2018

1

NO.	DATE	BY	REFERENCE

ZEIGER ENGINEERS, INC.
ELECTRICAL CONSULTANTS
TEL: 916-462-2821 FAX: 916-462-2809
CHECKED BY: _____
DESIGNED BY: _____
DRAWN BY: _____

PROFESSIONAL SEAL
STATE OF CALIFORNIA
REGISTERED ELECTRICAL ENGINEER
NO. 57478
DATE: 06/15/2010

Dillingham Associates
Landscape Architects
2327 Newbury Street
Oakland, CA 94609
Tel: 510.548.4700 Fax: 510.548.0205
www.dillinghamlandscape.com

BALLFIELD WIRING HAZARD MITIGATION AND LIGHTING PROJECT, CITY OF OAKLAND

CITY OF OAKLAND
DEPARTMENT OF ENGINEERING AND CONSTRUCTION
250 FRANK OAKMAN PLAZA, OAKLAND, CA, 94612
(510) 230-6637 - FAX: (510) 230-7227

EXISTING SPORTS LIGHTING				
POLE ID	HEIGHT	LUMINAIRES	QUANTITY PER POLE	REMARKS
A1	40'	1	1	1000
B1	40'	1	1	1000
C1	40'	2	(2)	1000 BACK TO BACK
A2	40'	2	(2)	1000 BACK TO BACK
B2	40'	2	(2)	1000 BACK TO BACK
C2	40'	2	(2)	1000


EXISTING SPORTS LIGHTING				
POLE ID	HEIGHT	LUMINAIRES		REMARKS
		QUANTITY PER POLE	HPS WATTS	
A1	40'	1	1000	
B1	40'	1	1000	
C1	40'	2	(2) 1000	BACK TO BACK
A2	40'	2	(2) 1000	BACK TO BACK
B2	40'	2	(2) 1000	BACK TO BACK
C2	40'	2	(2) 1000	BACK TO BACK

GENERAL NOTE:

1. REMOVE EXISTING FOUNDATIONS AND INSTALL NEW FOUNDATIONS WHERE INDICATED ON NEW ELECTRICAL PLAN SHEET ES.3

SHEET NOTES:

- ① REMOVE POLE, LUMINAIRES & FOUNDATION
- ② REMOVE EXISTING WIRES, CUT CONDUITS BELOW GRADE, (NO STUB OUT) & ABANDON CONDUIT IN PLACE

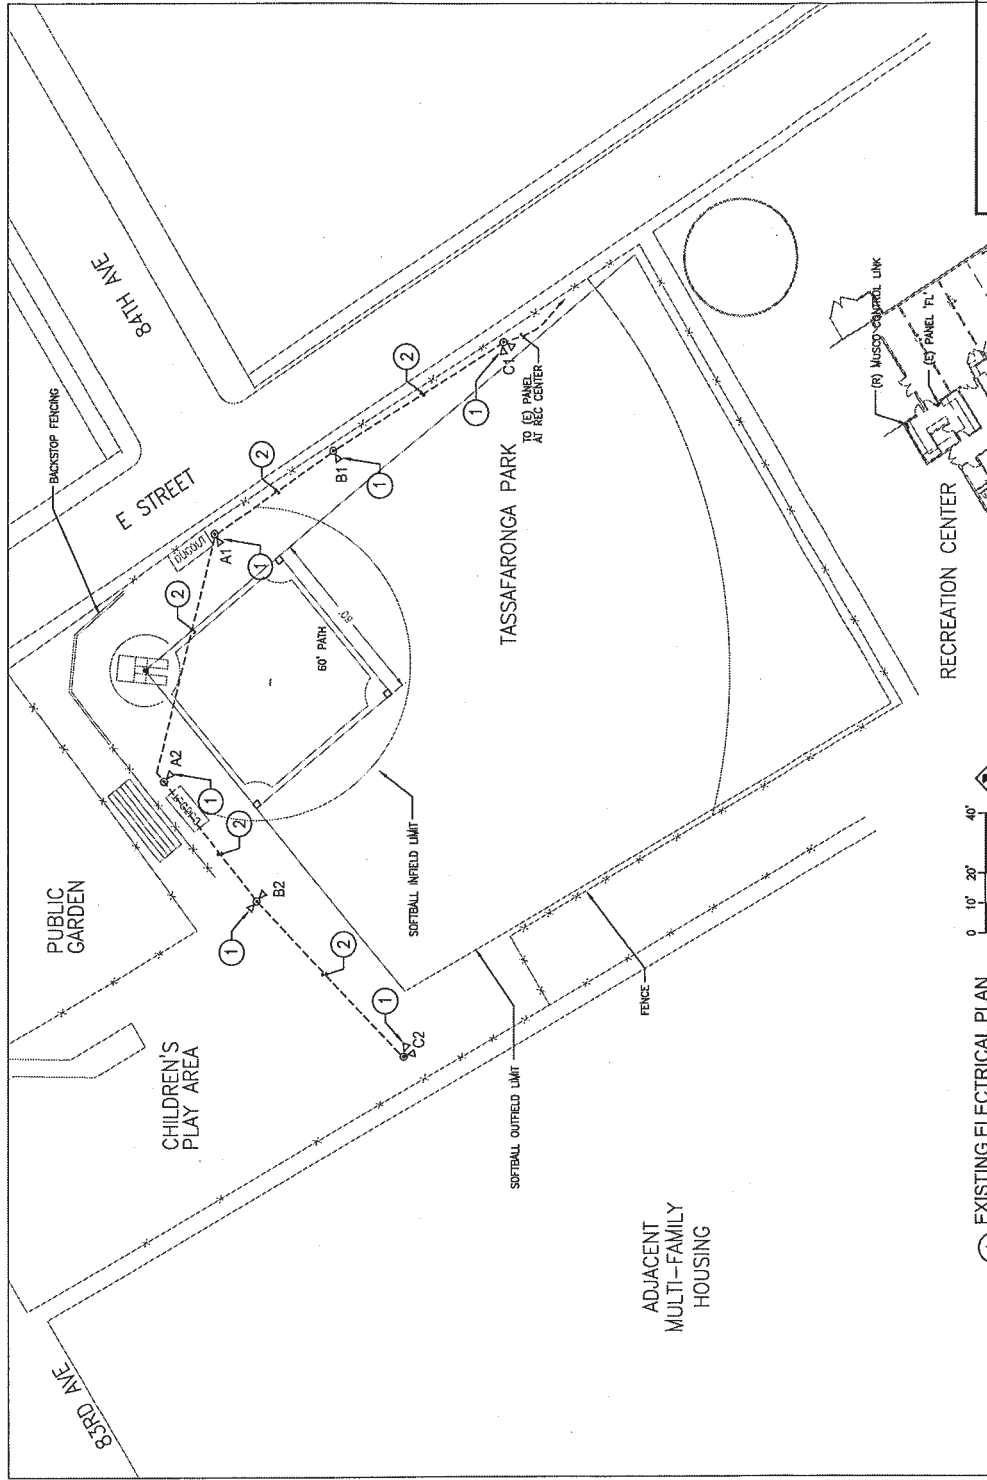

EXISTING ELECTRICAL PLAN
SCALE: 1" = 20'-0"

EXISTING ELECTRICAL PLAN
SCALE: 1" = 20'-0"

CITY OF OAKLAND
DEPARTMENT OF ENGINEERING AND CONSTRUCTION
250 FRANK OCEANA PLAZA, OAKLAND, CA 94612
(916) 230-6007 FAX: (916) 230-7221

Dillingham Associates
LANDSCAPE ARCHITECTS
2629 North 26th Street
Berkeley, California 94703
Tel: 510.548.4700 fax: 510.548.0285
www.dillinghamdexter.com

ZIGLER ENGINEERS, INC.
470 3RD STREET, OAKLAND, CA 94607
TEL: 510-462-2651 FAX: 510-462-0097
CHECKED BY: [Signature] OL
DESIGNED BY: [Signature] RZ
DRAWN BY: [Signature] AG

No.	DATE	BY	REFERENCE

EXISTING ELECTRICAL PLAN
TASSAFARONGA FIELD
975 85 AVE
OAKLAND, CA 94621

PROJECT NO. _____
SCALE: _____
DATE: _____
SHEET NO. _____
ES.2

95% CD SET


FILED BY: [Signature] DATE: [Date]
SCALE: 1" = 20'-0"
DATE: 08/27/13

SHEET NOTES:

- ① NIGHT OPERATION CHILDREN'S PLAY AREA LIGHT
- ② SPORT LIGHT WITH HIGH/LOW CONTROL FOR NIGHT SECURITY

SPORTS LIGHTING						REMARKS
FIELD POLES	HEIGHT	QUANTITY PER POLE	LED WATTS PER POLE	TOTAL WATTS PER POLE		
A1	50'	2	600	1200		
A2	50'	2	600	1200		
B1	60'	1	600	1200	UPLIGHT SECURITY LIGHT	
	15'	1	575	600		
B2	60'	3	600	1800	UPLIGHT NIGHT LIGHT AIMED AT CHILDREN'S PLAY AREA	
	15'	1	575	600		
C1	60'	2	600	1200		
C2	60'	2	600	1200	SECURITY LIGHT	
TOTAL:					10150	

FEEDER SCHEDULE FROM POLE TO (E) PANEL							
TAG NO.	POLE	CONDUIT	LOAD	WIRE	GROUND	DISTANCE	REMARKS
1	B2	2"	2 #8	2 #10	#6	L=350' L=250'	2.3 1.1
2	B2	2"	2 #8	2 #10	#6	L=350' L=250'	2.3 1.1
3	A2	2"	2 #8	2 #10	#10	L=600'	2.6
4	A2	2"	2 #10	2 #10	#10	L=500' L=400'	2.5 2.1
5	A1	2"	2 #10	2 #10	#10	L=500' L=400' L=250'	2.6 2.1 2.4
6	A2	2"	2 #10	2 #10	#10	L=500'	2.6

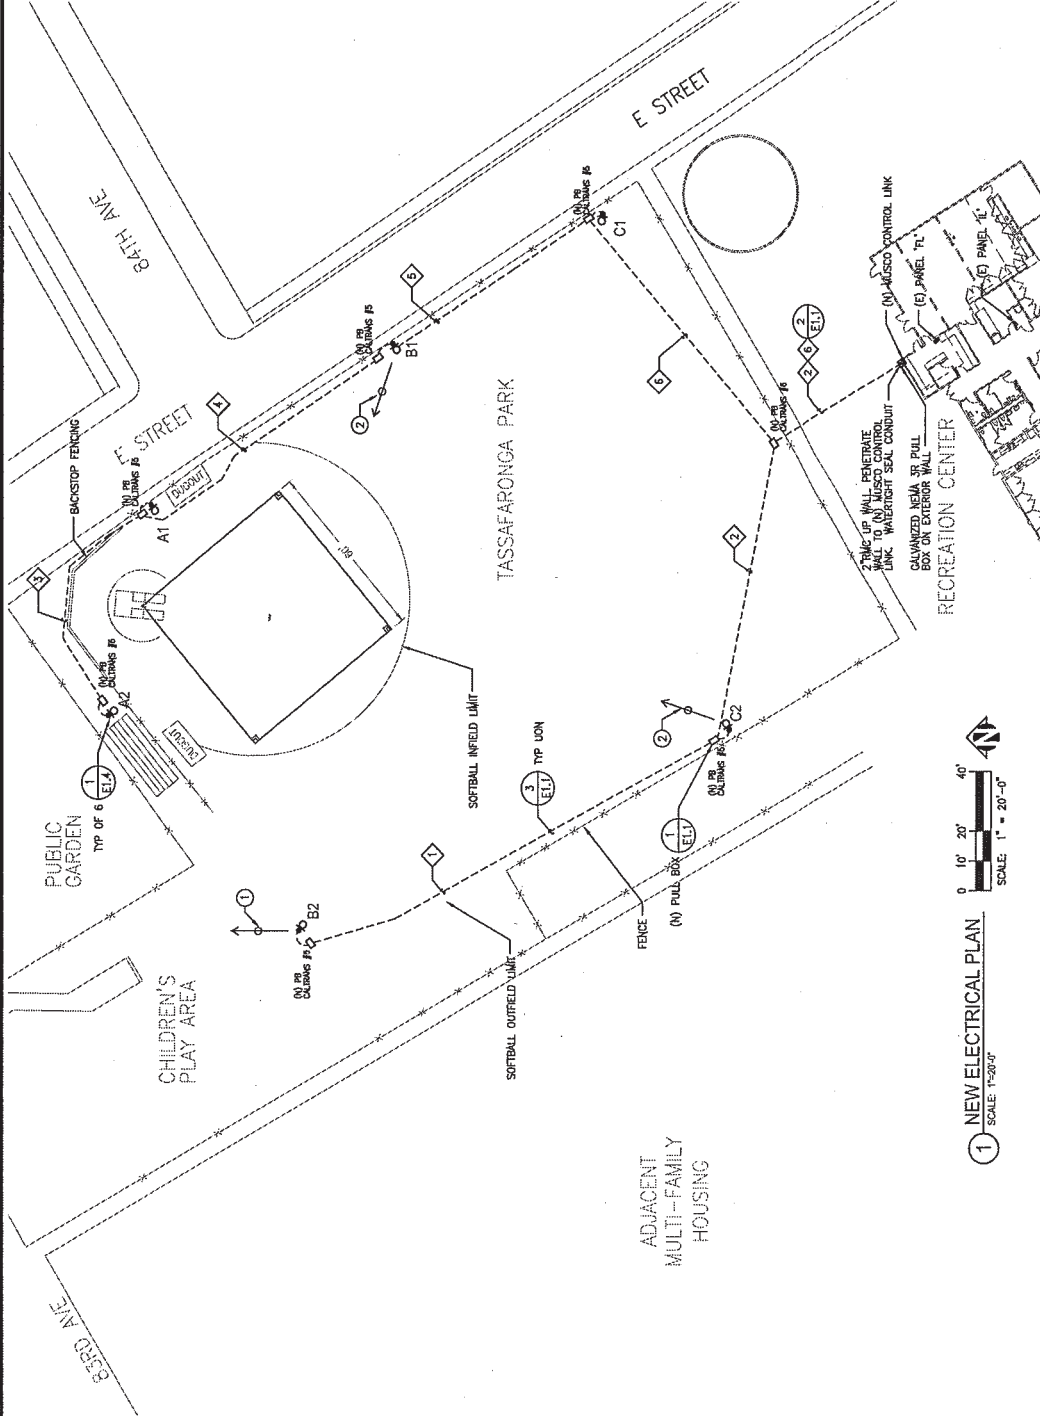

① NEW ELECTRICAL PLAN
SCALE: 1" = 20'-0"

95% CD SET

PROJECTING: PROJECT NO. SHEET NO. ES.3 SCALE: AS SHOWN DATE: 01/26/2018	
NEW ELECTRICAL PLAN TASSAFARONGA FIELD 975 85 AVE OAKLAND, CA 94621	
ZIEGLER ENGINEERS, INC. 400 9th STREET, OAKLAND, CA 94612 TEL: 510-548-2801 FAX: 510-548-0099 CHECKED BY: [Signature] DESIGNED BY: [Signature]	Dillingham Associates Landscape Architecture 2677 North Shoreline Blvd #100 Berkeley, California 94703 tel: 510-548-4700 fax: 510-548-0385 www.dillinghamassociates.com
BALLFIELD WIRING HAZARD MITIGATION AND LIGHTING PROJECT, CITY OF OAKLAND	
CITY OF OAKLAND DEPARTMENT OF ENGINEERING AND CONSTRUCTION 250 FRANK OGDEN PLAZA, OAKLAND, CA 94612 (916) 230-8222	



150 02/27/21



January 12, 2011


Subject: Importance of mounting heights for spill light control

To Whom It May Concern:


Pole heights are very important when it comes to sports lighting and spill control. We determine the required pole height based on the field size, the setback distance from the field, and what type of sport is to be played on the field. As the field size and setback distance increase, the pole height must increase as well so that the fixture is aimed steeper to minimize glare on and off of the field. Taller poles allow us to direct more light onto the field and reduce the amount of light that spills off of the field.

Below is an illustration of why taller poles create better spill light control. As the pole increases in height, the fixture aiming angles will become steeper and therefore more light is directed on to the field.

40' Poles

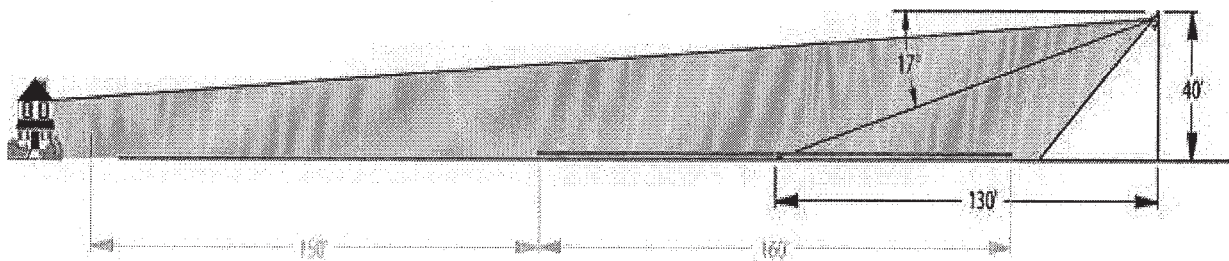

80' Poles

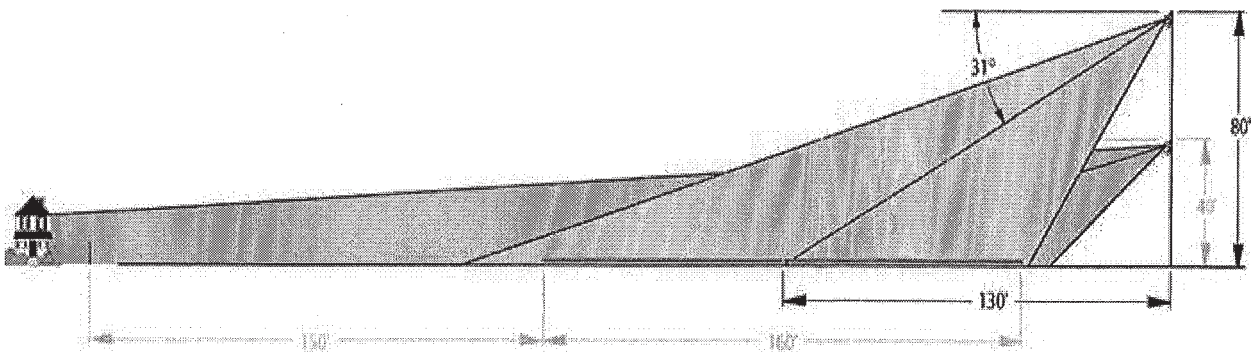

Musco has been in the Sports Lighting Industry for over 30 years. We pride ourselves on providing quality lighting systems that are custom for every location and application. We sell a high quality product and we make every effort to give our customers the most value possible. We care about safety on the field and we care about being good neighbors to properties around the field.

Regards,

Eric Svenby
Project Engineer
Musco Lighting
800-825-6025 ext 2118
eric.svenby@musco.com

Lighting . . . We Make It Happen.



**CITY OF OAKLAND
Oakland Parks & Recreation**

TO: Mandolin Kadera-Redmond, Chair, Parks and Recreation Advisory Commission
FROM: Denise Louie, CIP Coordinator, Public Works, Project Delivery Division
DATE: October 10, 2018
SUBJECT: REQUEST FOR THE PARKS AND RECREATION ADVISORY COMMISSION TO REVIEW AND PROVIDE COMMENT ON THE TWO (2) GIFT IN PLACE DESIGN OPTIONS BY OAKLAND ARTIST MUZAE SESAY FOR THE RAINBOW RECREATION CENTER PUBLIC ART PROJECT IN EAST OAKLAND, WITH FINAL DESIGN TO BE SELECTED BY TEENS OF THE DIGITAL ARTS AND CULINARY ACADEMY (DACA)

SUMMARY

Public Works and Parks & Recreation Staff recommend that the Parks and Recreation Advisory Commission receive a presentation and provide comment on the two (2) gift in place design options by Oakland artist Muzae Sesay for the Rainbow Recreation Center Public Art Project in East Oakland, with final design selection by teens of DACA.

Because of tight timing and required careful coordination in completing both the larger capital renovation project of the recreation center, the gift in place basketball courts renovation and the contracting for the gift in place still to be initiated, approval is out of typical sequence and this presentation to PRAC is done after Public Arts Advisory Committee's review of this project on October 1, 2018.

FISCAL IMPACT

Project Backboard funds this gift in place and therefore has no negative impact to the City. The project completes work (renovate basketball court) that has been identified as a community wish list item to the existing capital improvement project. Upon receiving comments from PRAC, the City will execute the necessary contracts with Project Backboard/parties to perform the work.

PROJECT / PROGRAM DESCRIPTION

The Rainbow Recreation Center is located at 5800 International Boulevard, Oakland, CA 94621 (District 6).

The Center is used by local families and children, and offers a range of programming, classes, and camps. The capital improvement renovation and expansion project includes a gym, kitchen, food distribution pantry, daycare room, computer and multi-purpose areas in addition to exterior basketball courts, skateboard and new practice soccer/flag football field and open space. The rebuilt center is scheduled to be completed in early 2019.

Project Backboard is a non-profit devoted to ensuring all communities have a safe and inviting place

to play outdoor basketball by renovating public outdoor courts and collaborate with an artist to create unique works of art for the surface of the court. Project Backboard will renovate the two existing exterior basketball courts and resurface the courts utilizing standard court color coatings and techniques.

During Summer 2018, Mr. Sesay provided the opportunity for teens at DACA to input on the design. Mr. Sesay took the input from the sessions to create two design concepts fitting for the exterior courts. In the near future, teens from DACA will select one of the concepts as the work to be painted onto the two exterior basketball courts.

The project must be carefully coordinated with the capital improvement project which already has a tight timeline due to a grant expiration. The court renovation and painting completion will be celebrated at the same time as the facility grand opening.

The two design options along with concept descriptions are attached.

BACKGROUND / LEGISLATIVE HISTORY

On June 5, 2018, City Council approved the recommendation to receive a gift in place from Project Backboard for the Rainbow Recreation Center located at 5800 International Boulevard, Oakland CA 94621. The gift in place project was authorized in Resolution 87223 C.M.S.

RECOMMENDATION

Public Works and Parks & Recreation Staff recommend that the Parks and Recreation Advisory Commission receive a presentation and provide comment on the two (2) gift in place design options by Oakland artist Muzae Sesay for the Rainbow Recreation Center Public Art Project in East Oakland, with final design selection by teens of DACA.

In compliance with the gift in place, the proposed project will enhance the community center by renovating the exterior basketball courts and rejuvenate the exterior space with artwork created with community engagement, serving the needs of the Rainbow Recreation Center users and surrounding neighborhood.

Respectfully submitted,



Prepared by: Denise Louie, CIP Coordinator

Attachments: Exhibit A – *Rainbow Recreation Center Exterior Basketball Court Design Options*


Exhibit A: Rainbow Recreation Center Exterior Basketball Court Design Options



Design #1: *Our Rainbows*

A design that utilizes the dimensions of the basketball courts to depict reflecting, diverse worlds. Four irregular colored rainbows mark the three point lines and represent the beauty of unconventional and unique blending. Within the rainbow are open paths, open doors, stairways, windows, and horizons symbolizing the idea that “tolerance and diversity open opportunities for everyone. The center court becomes the horizon line for reflecting worlds; one representing a setting sun and the other a full moon on horizon. The ladder, bricks, bridged line, and structure are all symbols that contribute to the idea of prosperity through diversity.

Exhibit A: Rainbow Recreation Center Exterior Basketball Court Design Options

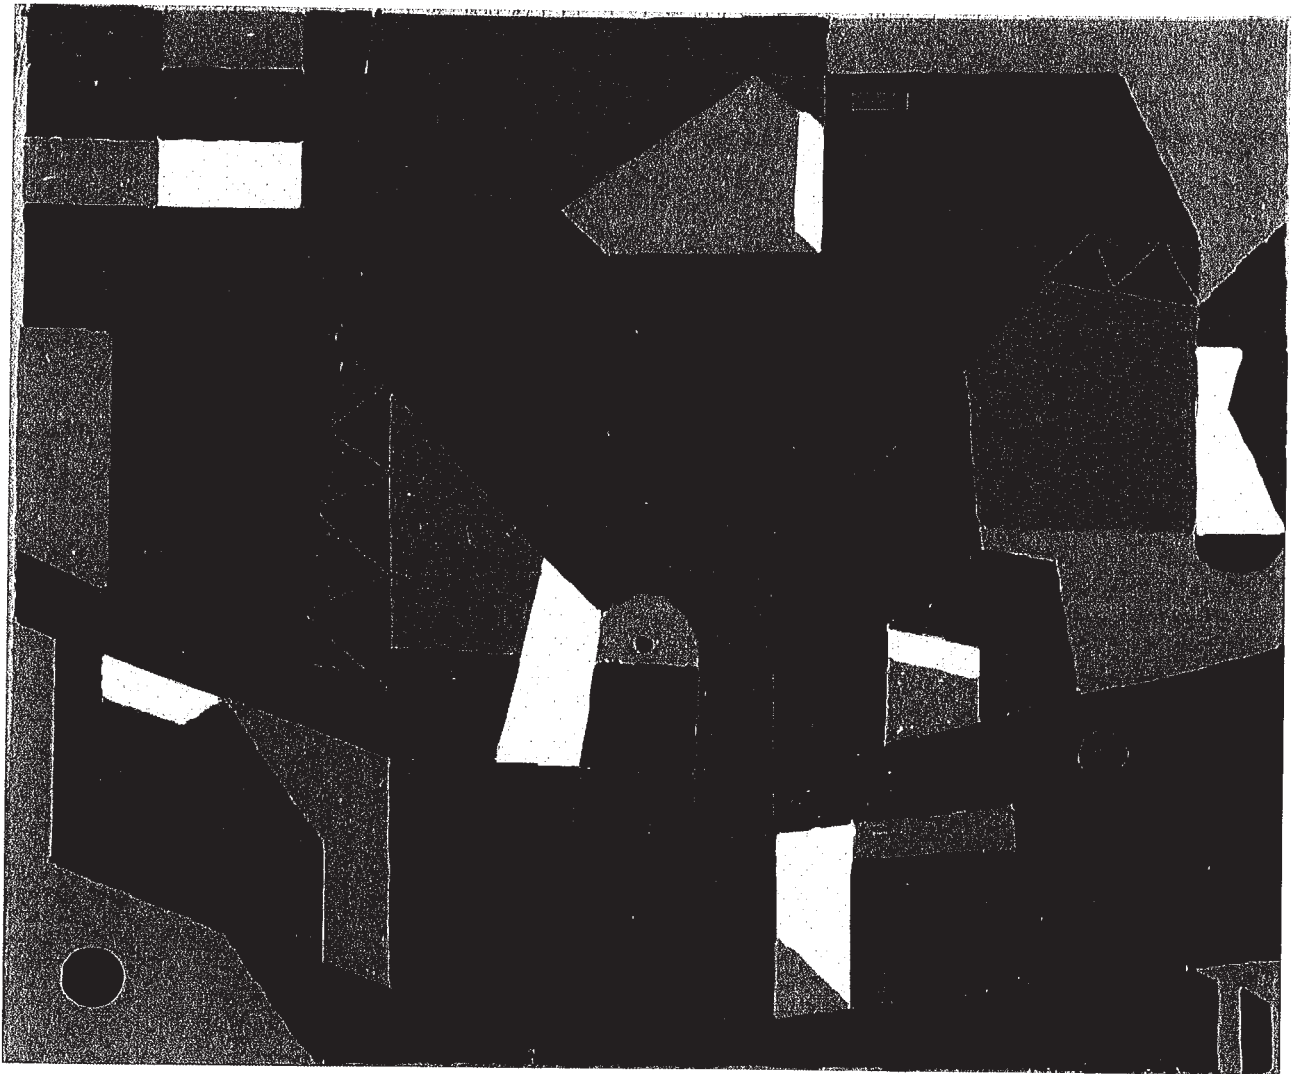

Design #2: *Homecourt*

A full court design that is a blend between an interior domestic scene and a scene from the Port of Oakland. The shape of the house becomes meshed with an image of an iconic Oakland port crane over a sun setting waterfront with shipping containers.